


Municipality of Middlesex Centre

Lot 5

Concession 9

(Geographic Township of Lobo)


Part 1, Plan 33R -- 11395

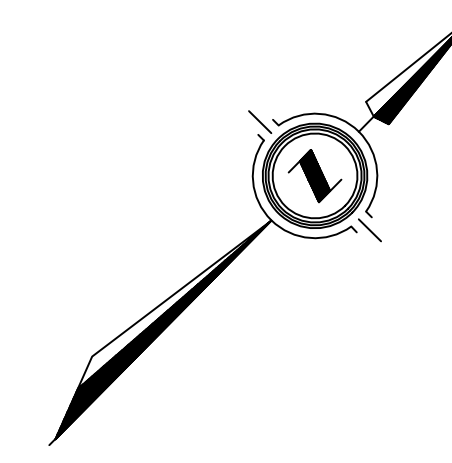

Lot 23
35M -- 38

Lot 22
Plan

CONCEPT PLAN
 OF PART OF
LOT 5, CONCESSION 9
 (GEOGRAPHIC TOWNSHIP OF LOBO)
 IN THE
MUNICIPALITY OF MIDDLESEX CENTRE
 COUNTY OF MIDDLESEX
 SCALE 1:500
 10 8 6 4 2 0 10 20 30
 SCALE IN METRES
 2018
 ARCHIBALD, GRAY & McKAY LTD.
 ONTARIO LAND SURVEYORS

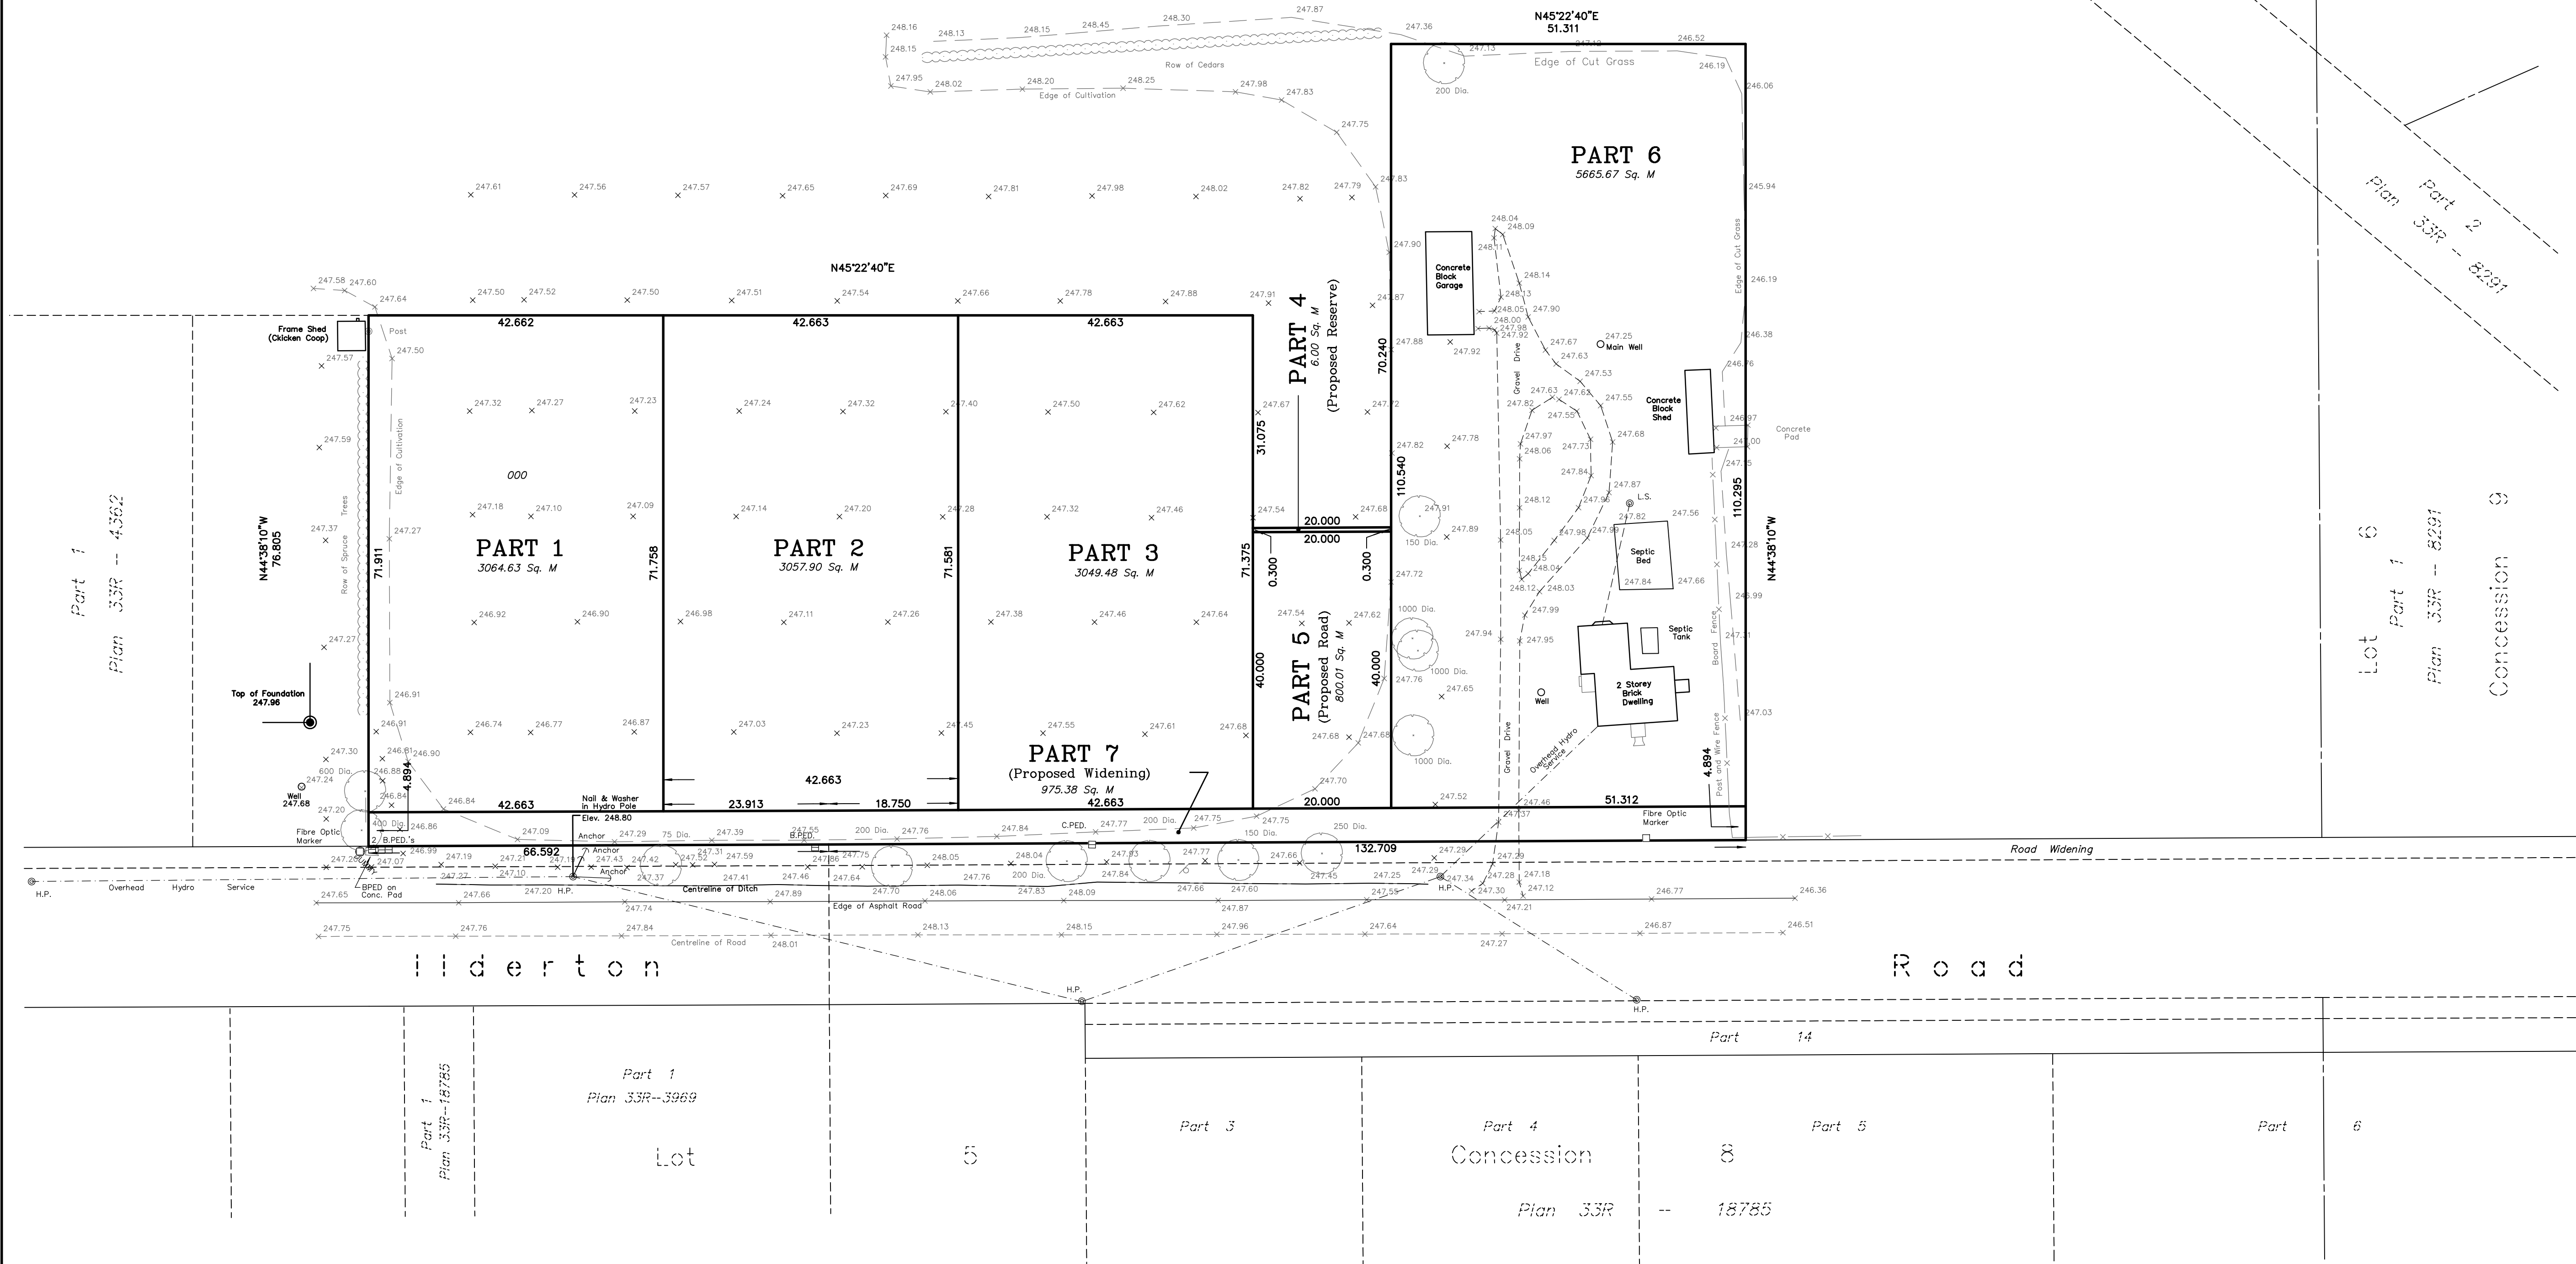

Lot 6
Part 1
Plan 33R -- 8291
Concession 9

Midderton

Road

Part 1
Plan 33R--18785
Lot 5

Part 3

Part 4
Concession 8

Part 5

Part 6

Plan 33R -- 18785

AGM ARCHIBALD, GRAY & McKAY LTD.
 3514 WHITE OAK ROAD, LONDON, ON, N6E 2Z9
 PHONE 519-665-5300 FAX 519-665-5303
 EMAIL info@agm.on.ca WEB www.agm.on.ca

DRAWN BY: JGH	DIGITAL FILE: LO1805K2MS17.dwg	PLAN No:
CHECKED BY: DDC	FILE No: LO-57-1	9-L-5170
Plot date: May 15, 2018		